


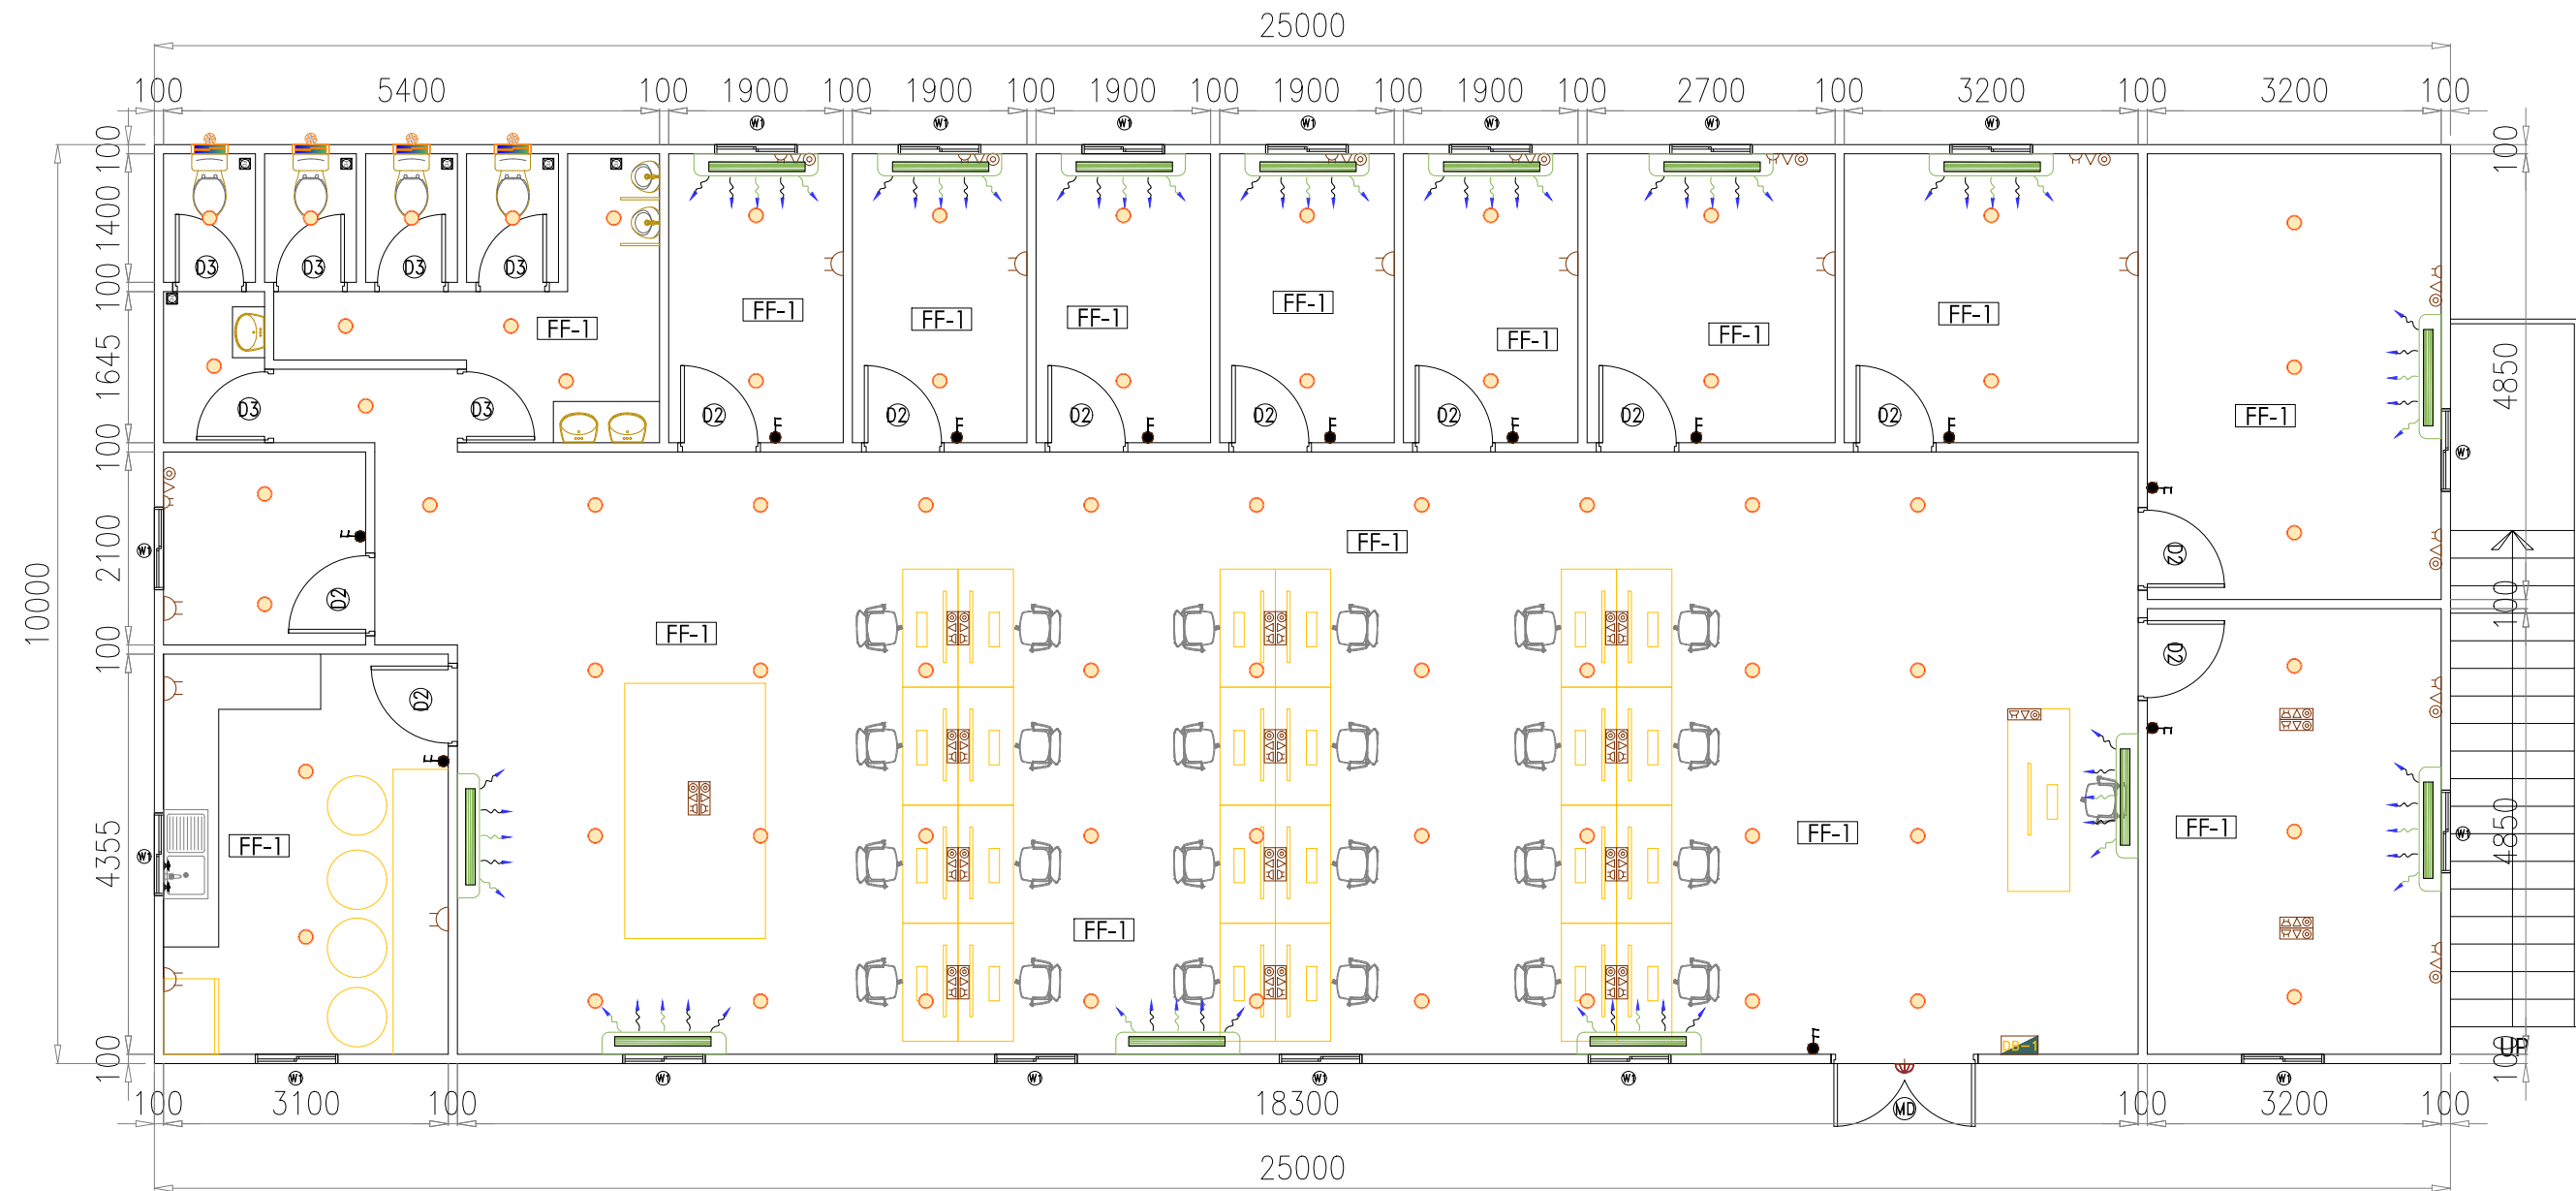

GROUND FLOOR LAYOUT
SCALE: 1:40

DOOR SHEDULE			
MD	01	EXTERNAL DOOR: FULL FRAME ALU./STEEL DOUBLE LEAF DOOR	1600x2100
D1	00	EXTERNAL DOOR: FULL FRAME ALU./STEEL SINGLE LEAF DOOR	900x2100
D2	11	INTERNAL DOOR: WPVC WOODEN SINGLE LEAF DOOR	900x2100
D3	05	TOILET DOOR: WPVCDOOR/SEMI SOLID WOODEN DOOR ENAMEL PAINTED	800x2100

WINDOW SHEDULE			
W1	17	ALU.SLID.WIN. ALUMINIUM FRAME 6MM THICK TEMPERED GLASS SLIDING WINDOW	900x900
	05	ALU.FRAME 6MM GLAZED VENTILATOR	400x400

FLOOR FINISHING DETAIL		
FF-1	FLOOR FINISH 18MM THICK CEMENT BOARD DECKING WITH 1.5MM THICK PVC VINYL SHEET	

KEY PLAN:

NOTES:

- ALL DIMENSIONS ARE IN MILLIMETERS UNLESS OTHERWISE SPECIFIES
- DRAWINGS SHALL NOT BE SCALED. FOLLOW WRITTEN DIMENSIONS.
- ALL DIMENSIONS TO BE VERIFIED ON SITE. ANY DISCREPANCIES SHOULD BE NOTIFIED TO THE ENGINEER.
- READ THIS DRAWING IN CONJUNCTION WITH ALL CONSULTANTS AND SPECIALIST DRAWINGS, DETAILS, SCHEDULES AND SPECIFICATION
- FOR RAMP DETAIL REFER TO P158.02-DL-PTS-SD-SAN-MI-9143.

ELECTRICAL LEGEND

	13A SWITCH SOCKET(Double)
	15A SWITCH SOCKET
	ISOLATOR-32A (IP 65, TP/SP)
	DISTRIBUTION BOARD
	ONE GANG ONE WAY SWITCH
	TWO GANG TWO WAY SWITCH
	DATA POINT (provision only)
	TEL. POINT (provision only)
	600x600 LED LIGHT
	FLUORESCENT FITTING-2x36w
	FLUORESCENT FITTING-2x18w
	1.5 TON AC INDOOR UNIT
	BULKHEAD LAMP
	EXHAUST FAN (6")

PLUMBING LEGEND

	W/C EUROPEAN		KITCHEN SINK
	W/C ASIAN		WATER HEATER
	WASH BASIN		FLOOR TRAP
	URINAL		WATER TAP
	SHOWER TRAY		

03			
02			
01			
00	29-04-2025	FOR APPROVAL	HN
REV.	DATE:	DESCRIPTION	APPROVED BY:

CLIENT:

PROJECT/CONTRACT:

DRAWING TITLE:

G+1 SITE OFFICE CABIN

DRAWN BY: HASSAN NAWAZ

CHECK BY:

SCALE: 1:40


DATE: 29-04-2025

ACTUAL SIZE: A3

DRAWING NO.:

REV.:

00

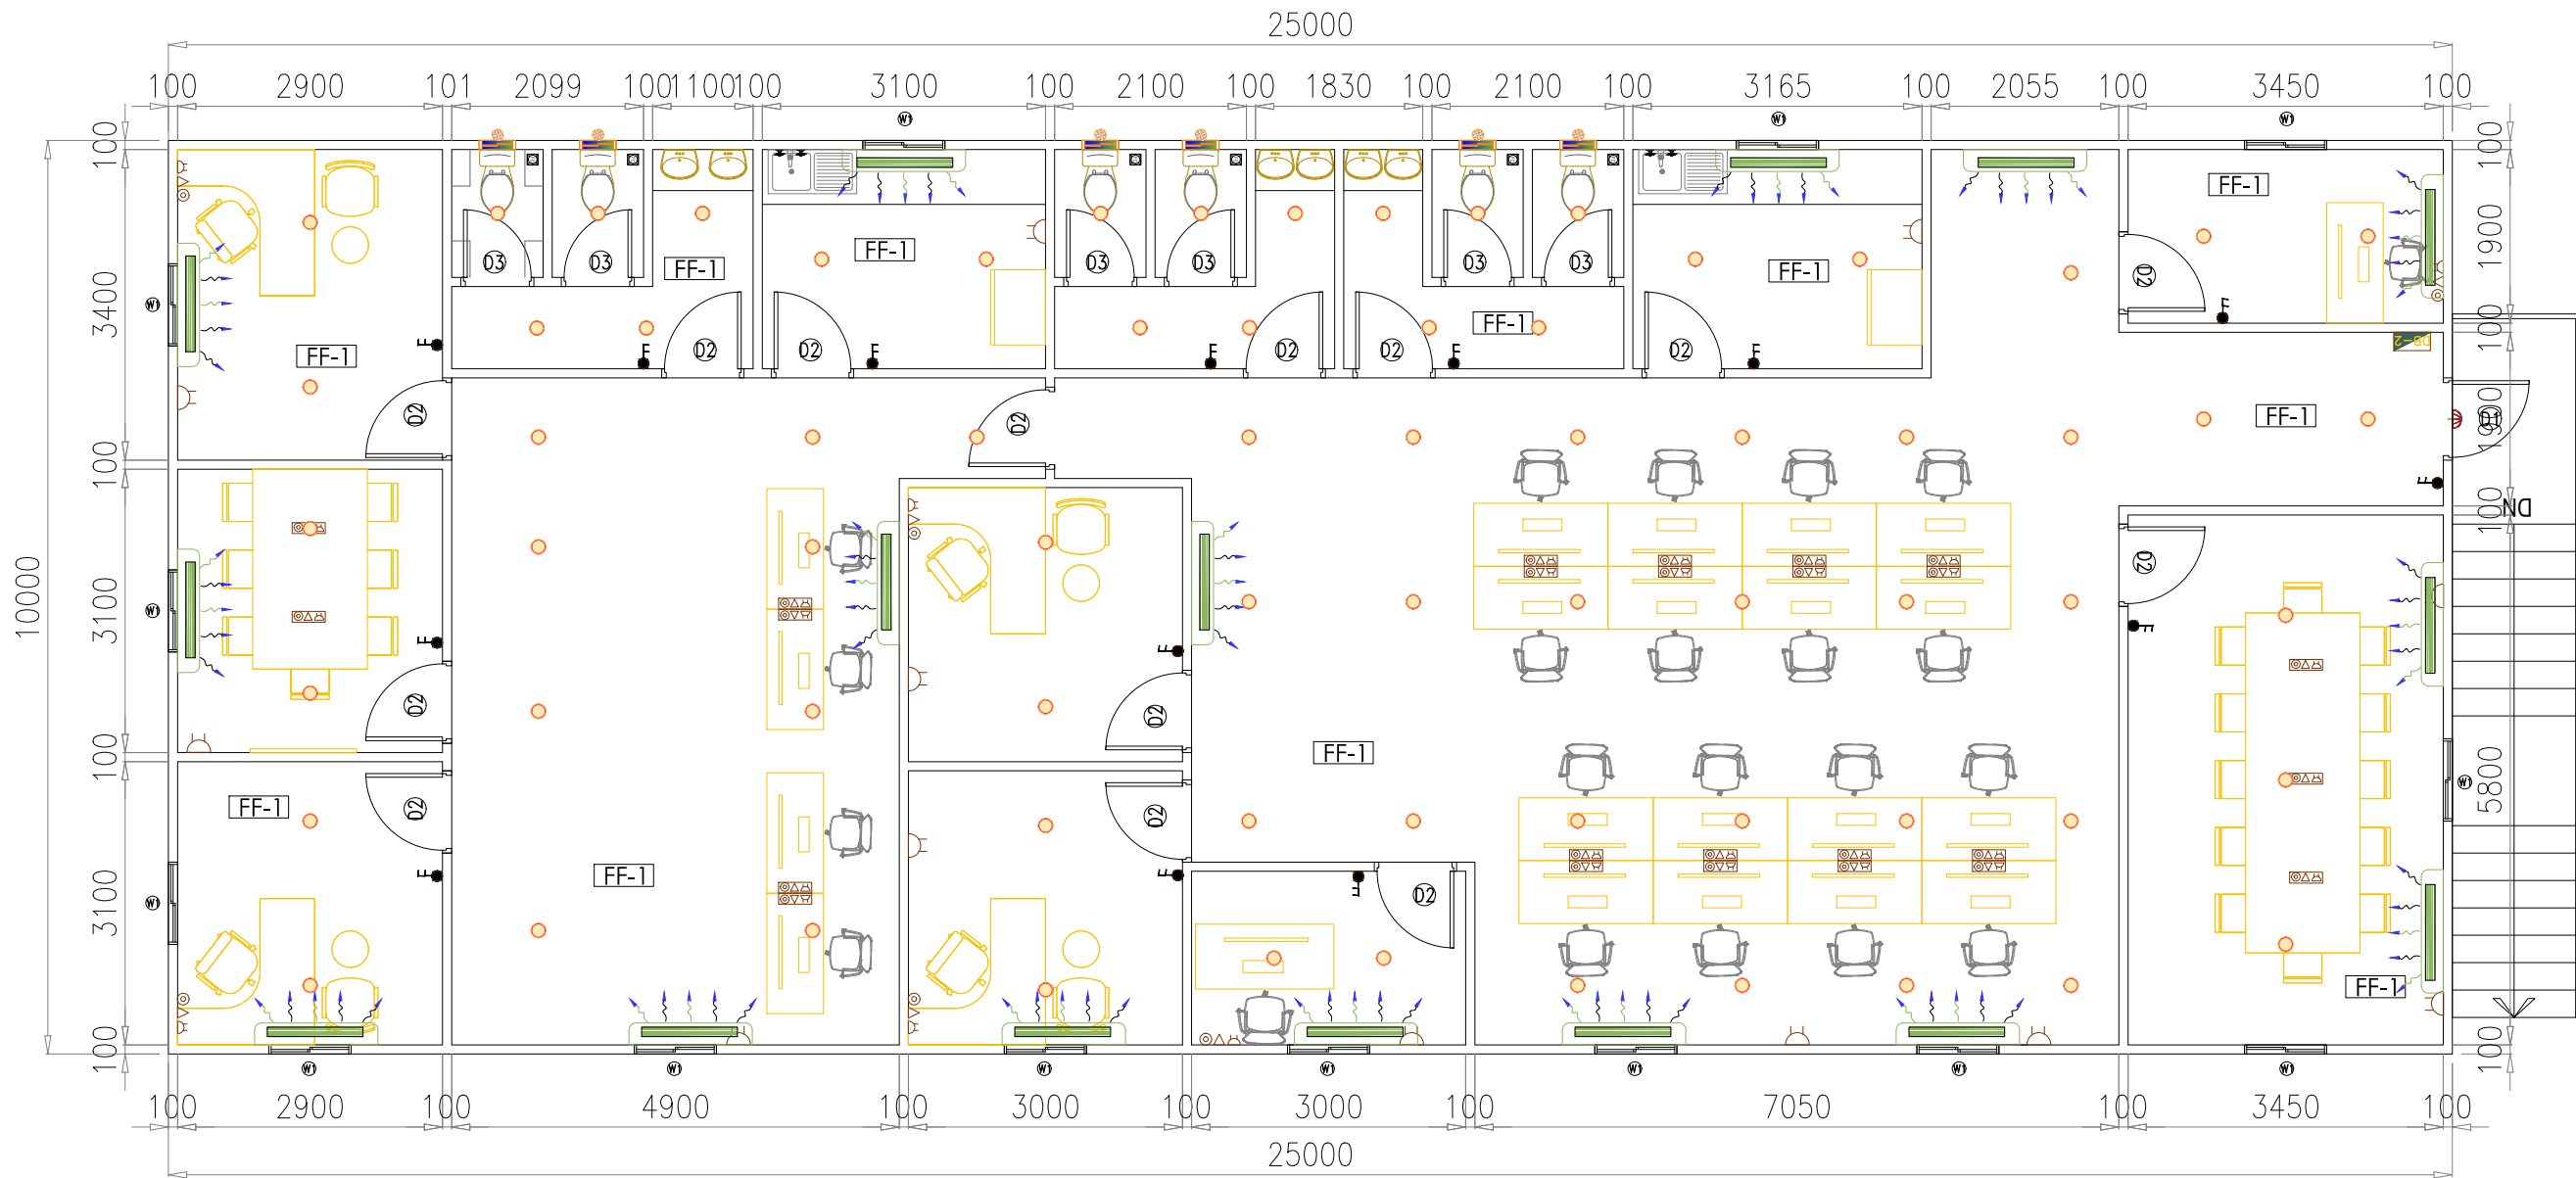

FIRST FLOOR LAYOUT
SCALE: 1:40

DOOR SHEDULE				WINDOW SHEDULE			
D1	01	EXTERNAL DOOR: FULL FRAME ALU./STEEL SINGLE LEAF DOOR	900x2100	W1	14	ALU.SLID.WIN. ALUMINIUM FRAME 6MM THICK TEMPERED GLASS SLIDING WINDOW	900x900
D2	13	INTERNAL DOOR: WPVC WOODEN SINGLE LEAF DOOR	900x2100				
D3	06	TOILET DOOR: WPVCDOOR/SEMI SOLID WOODEN DOOR ENAMEL PAINTED	800x2100	V1	06	ALU.FRAME 6MM GLAZED VENTILATOR	400x400

FLOOR FINISHING DETAIL		
FF-1	FLOOR FINISH 18MM THICK CEMENT BOARD DECKING WITH 1.5MM THICK PVC VINYL SHEET	

KEY PLAN:

NOTES:

- ALL DIMENSIONS ARE IN MILLIMETERS UNLESS OTHERWISE SPECIFIES
- DRAWINGS SHALL NOT BE SCALED. FOLLOW WRITTEN DIMENSIONS.
- ALL DIMENSIONS TO BE VERIFIED ON SITE. ANY DISCREPANCIES SHOULD BE NOTIFIED TO THE ENGINEER.
- READ THIS DRAWING IN CONJUNCTION WITH ALL CONSULTANTS AND SPECIALIST DRAWINGS, DETAILS, SCHEDULES AND SPECIFICATION
- FOR RAMP DETAIL REFER TO P158.02-DL-PTS-SD-SAN-MI-9143.

ELECTRICAL LEGEND

	13A SWITCH SOCKET(Double)
	15A SWITCH SOCKET
	ISOLATOR-32A (IP 65,TP/SP)
	DISTRIBUTION BOARD
	ONE GANG ONE WAY SWITCH
	TWO GANG TWO WAY SWITCH
	DATA POINT (provision only)
	TEL. POINT (provision only)
	600x600 LED LIGHT
	FLUORESCENT FITTING-2x36w
	FLUORESCENT FITTING-2x18w
	1.5 TON AC INDOOR UNIT
	BULKHEAD LAMP
	EXHAUST FAN (6")

PLUMBING LEGEND

	W/C EUROPEAN		KITCHEN SINK
	W/C ASIAN		WATER HEATER
	WASH BASIN		FLOOR TRAP
	URINAL		WATER TAP
	SHOWER TRAY		

03			
02			
01			
00	29-04-2025	FOR APPROVAL	HN
REV.	DATE:	DESCRIPTION	APPROVED BY:

CLIENT:

CLIENT

PROJECT/CONTRACT:

DRAWING TITLE:

G+1 SITE OFFICE CABIN

DRAWN BY: HASSAN NAWAZ

CHECK BY:

SCALE: 1:40


DATE: 29-04-2025

ACTUAL SIZE: A3


DRAWING NO.:

REV.:

00

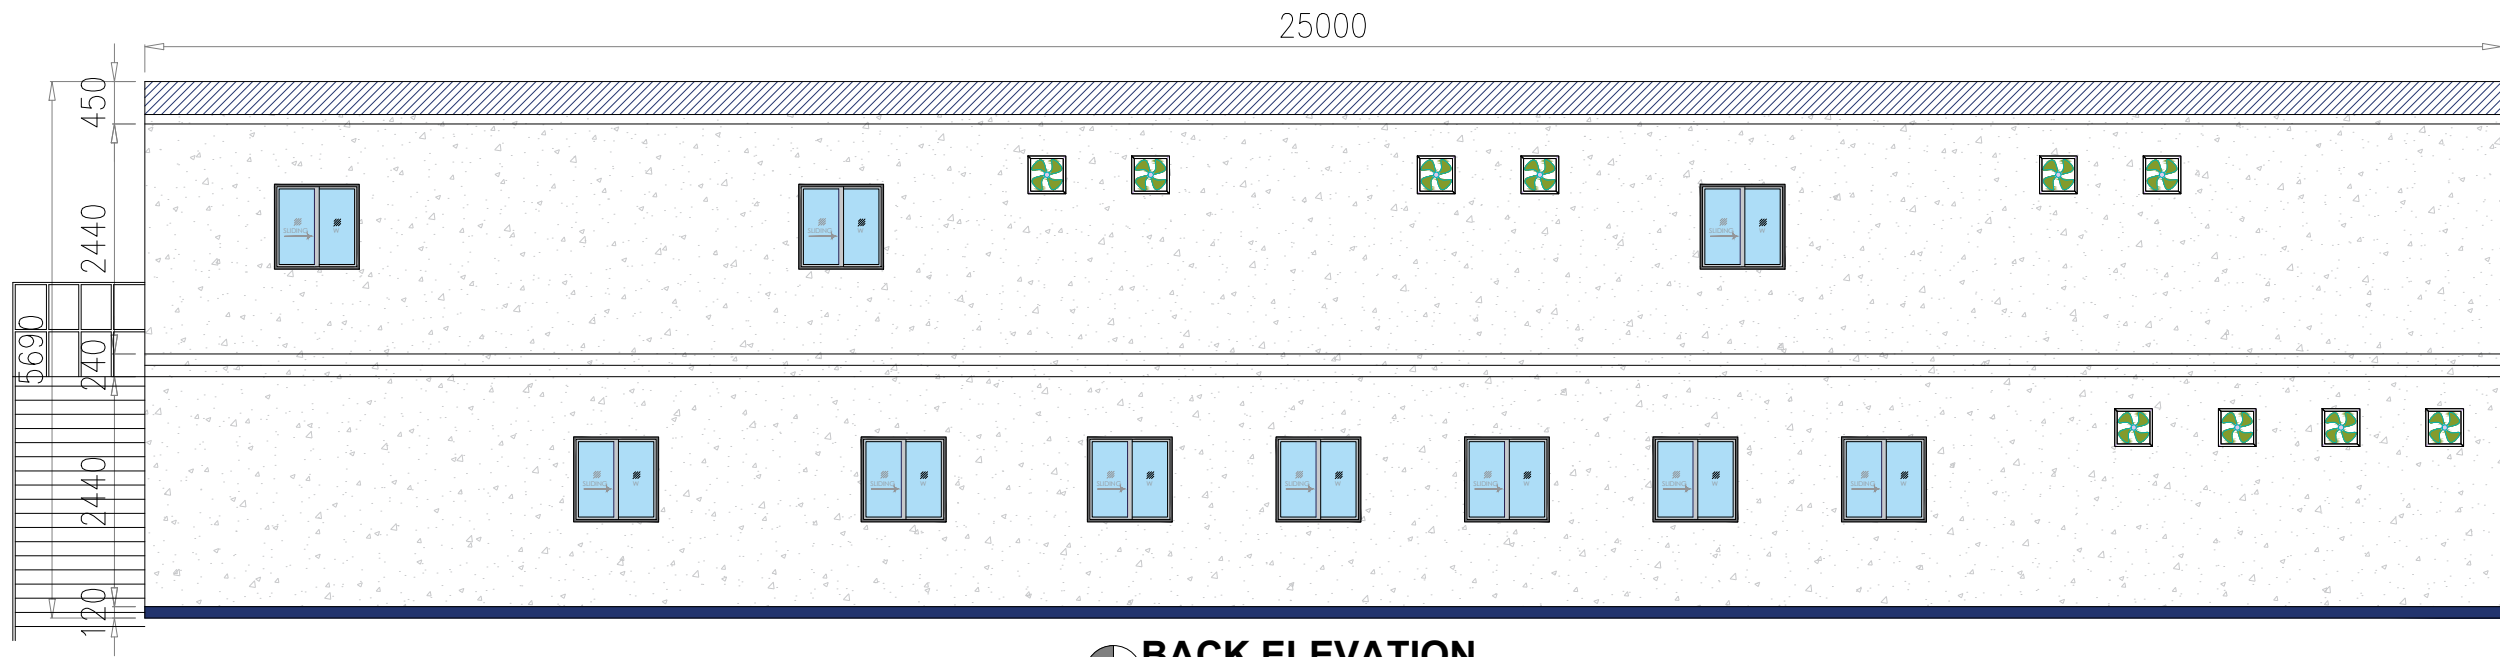

BACK ELEVATION
SCALE: 1:40

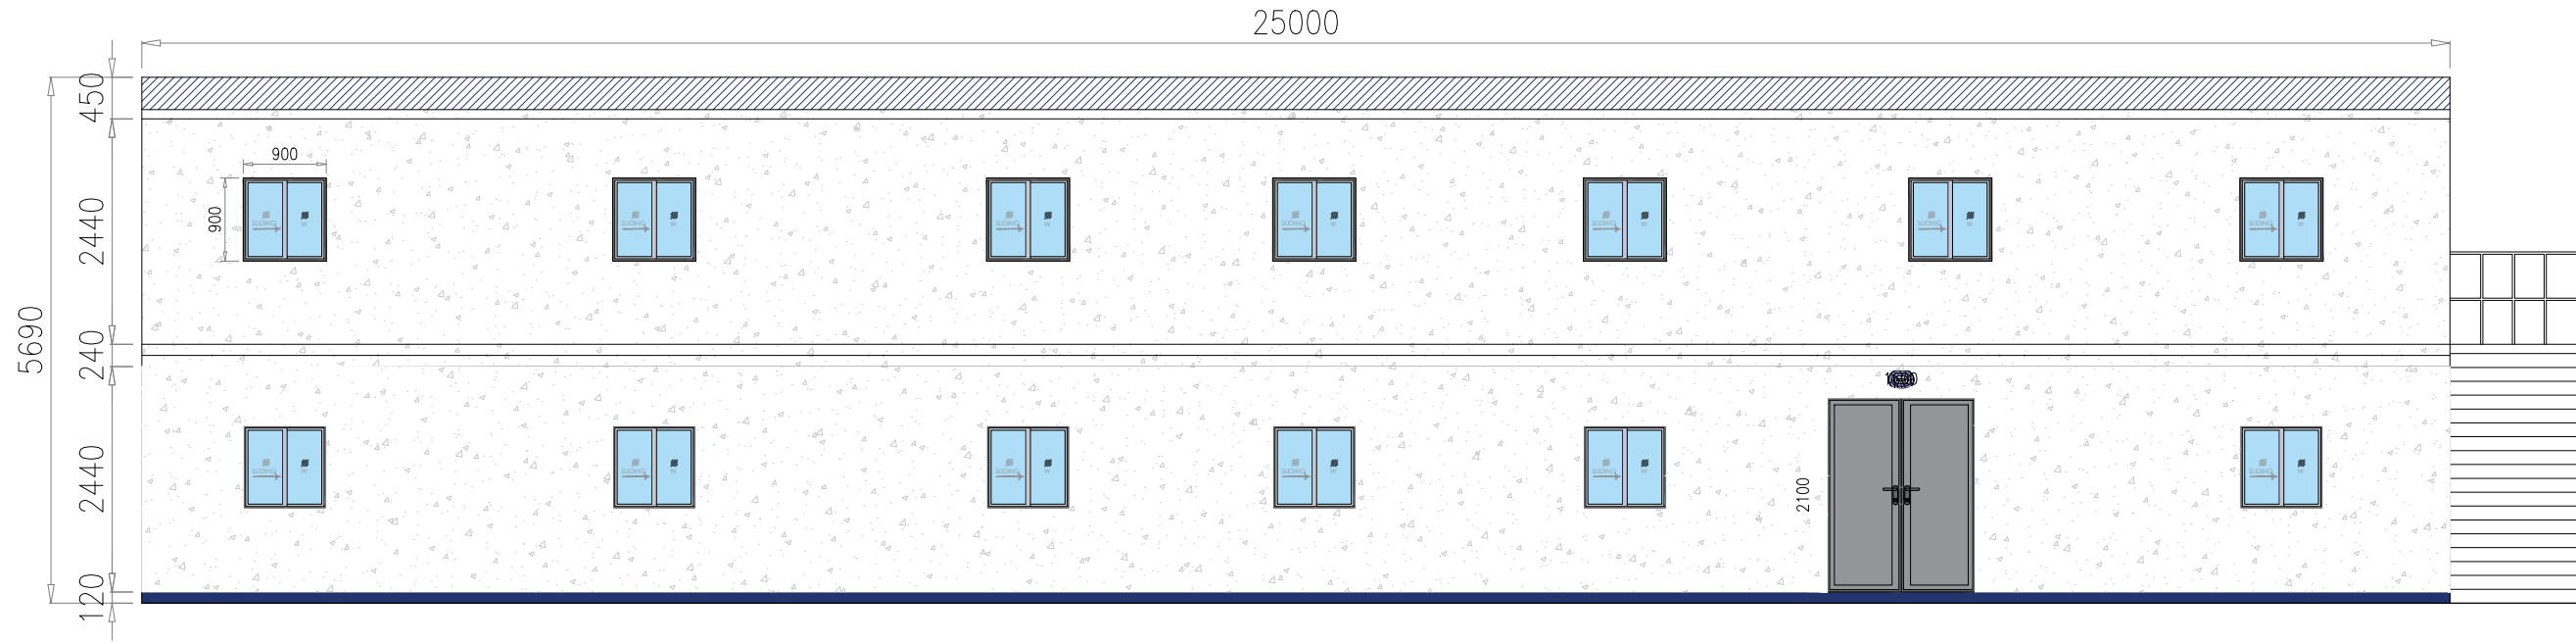

FRONT ELEVATION
SCALE: 1:40

KEY PLAN:

NOTES:

1. ALL DIMENSIONS ARE IN MILLIMETERS UNLESS OTHERWISE SPECIFIES
2. DRAWINGS SHALL NOT BE SCALED. FOLLOW WRITTEN DIMENSIONS.
3. ALL DIMENSIONS TO BE VERIFIED ON SITE. ANY DISCREPANCIES SHOULD BE NOTIFIED TO THE ENGINEER.
4. READ THIS DRAWING IN CONJUNCTION WITH ALL CONSULTANTS AND SPECIALIST DRAWINGS, DETAILS, SCHEDULES AND SPECIFICATION
5. FOR RAMP DETAIL REFER TO P158.02-DL-PTS-SD-SAN-MI-9143.

03			
02			
01			
00	29-04-2025	FOR APPROVAL	HN
REV.	DATE	DESCRIPTION	APPROVED BY:

CLIENT:



PROJECT/CONTRACT:

DRAWING TITLE:

G+1 SITE OFFICE CABIN

DRAWN BY:	CHECK BY:	
HASSAN NAWAZ		
SCALE:	DATE:	ACTUAL SIZE:
1:40	29-04-2025	A3
DRAWING NO. :		REV. :

00

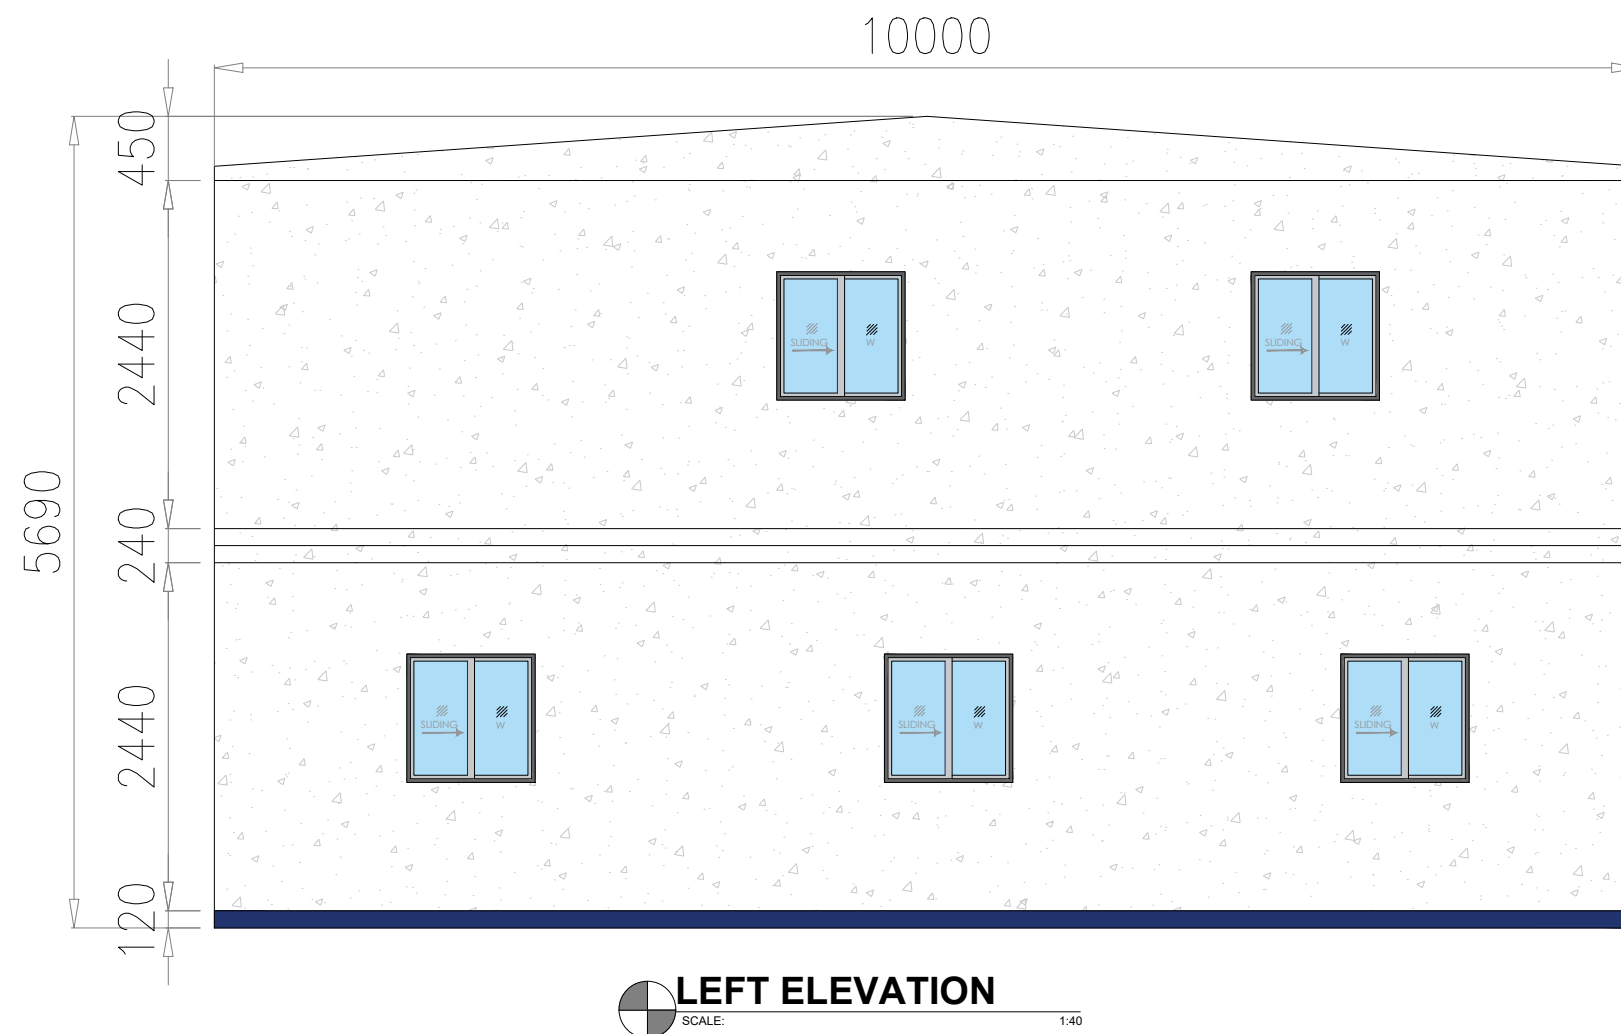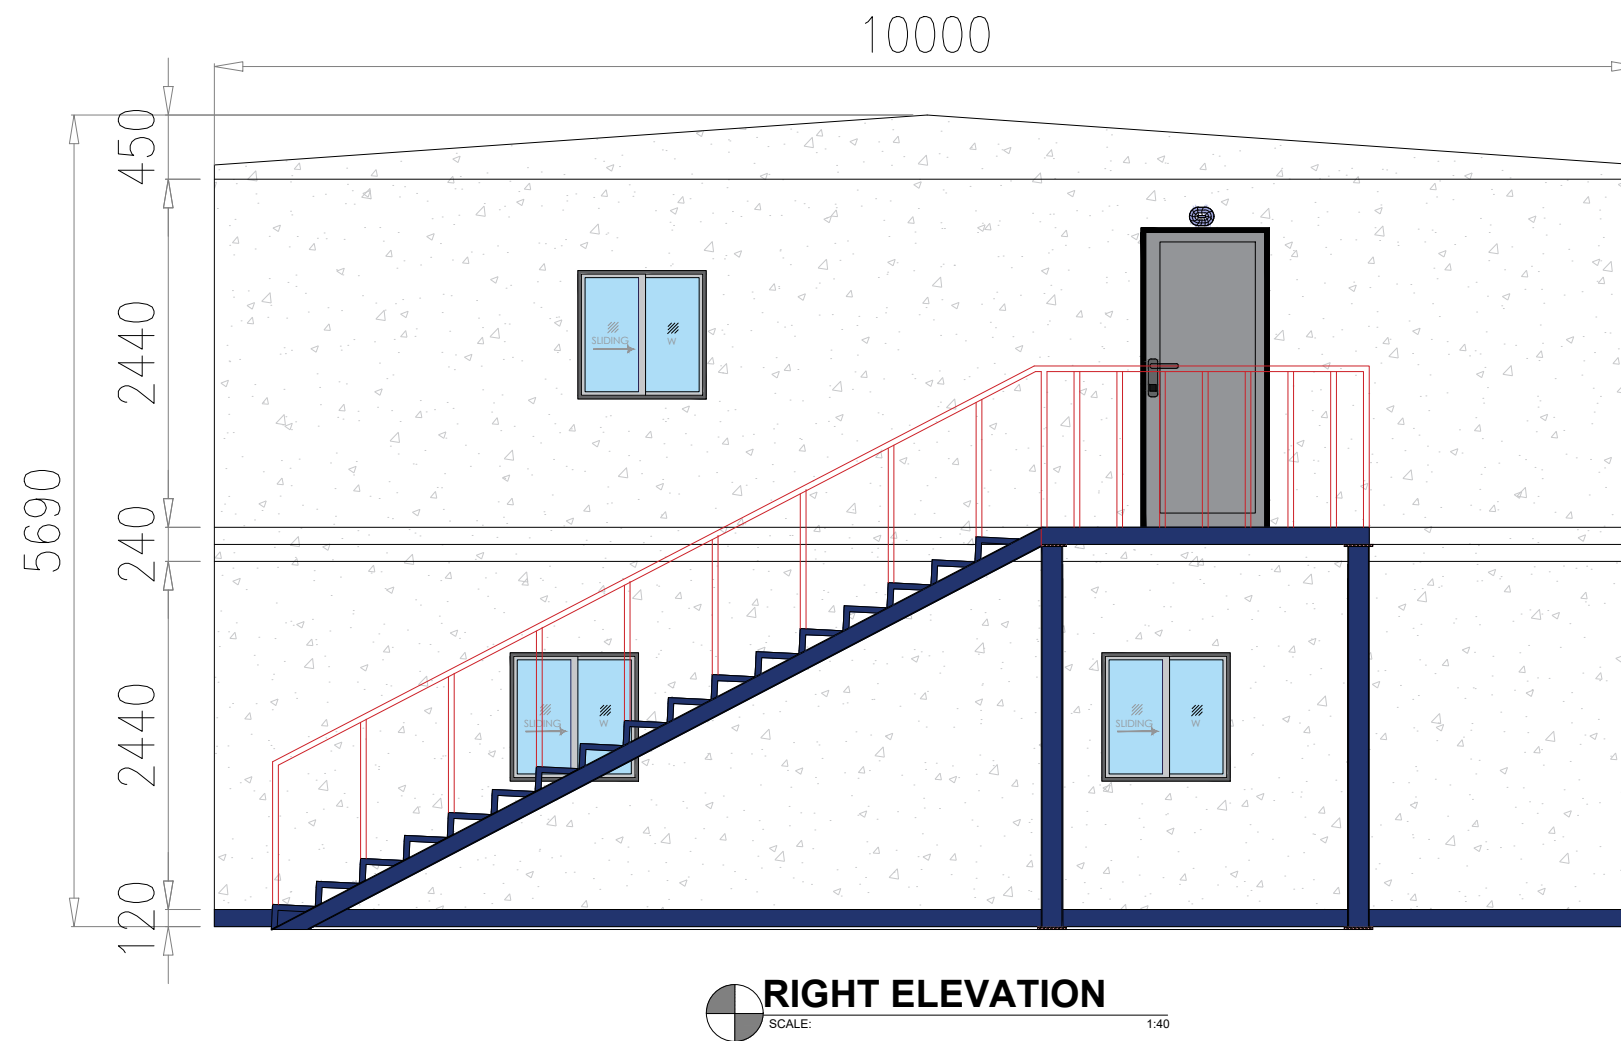

KEY PLAN:

- NOTES:
1. ALL DIMENSIONS ARE IN MILLIMETERS UNLESS OTHERWISE SPECIFIES
 2. DRAWINGS SHALL NOT BE SCALED. FOLLOW WRITTEN DIMENSIONS.
 3. ALL DIMENSIONS TO BE VERIFIED ON SITE. ANY DISCREPANCIES SHOULD BE NOTIFIED TO THE ENGINEER.
 4. READ THIS DRAWING IN CONJUNCTION WITH ALL CONSULTANTS AND SPECIALIST DRAWINGS, DETAILS, SCHEDULES AND SPECIFICATION
 5. FOR RAMP DETAIL REFER TO P158.02-DL-PTS-SD-SAN-MI-9143.

03			
02			
01			
00	29-04-2025	FOR APPROVAL	HN
REV.	DATE:	DESCRIPTION	APPROVED BY:



CLIENT:

PROJECT/CONTRACT:

DRAWING TITLE:
G+1 SITE OFFICE CABIN

DRAWN BY:	CHECK BY:		
HASSAN NAWAZ	DATE:	ACTUAL SIZE:	
SCALE:	1:40	29-04-2025	A3
DRAWING NO. :	REV. :		

00

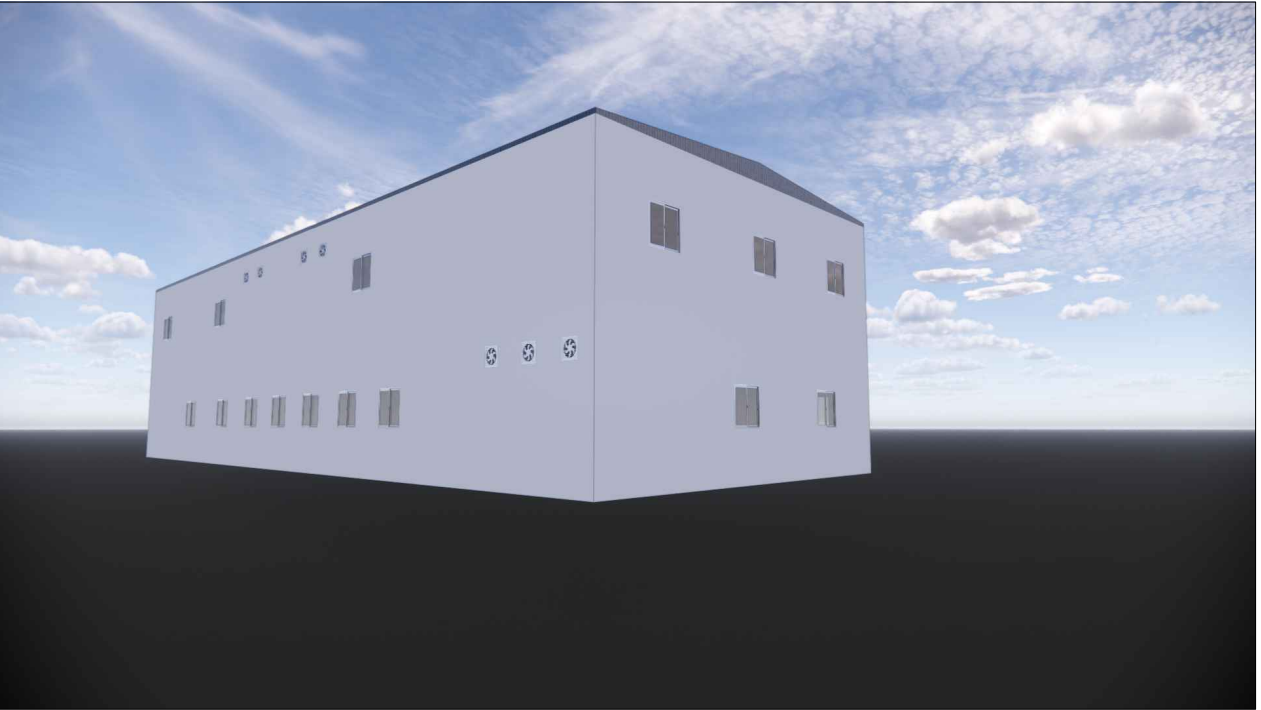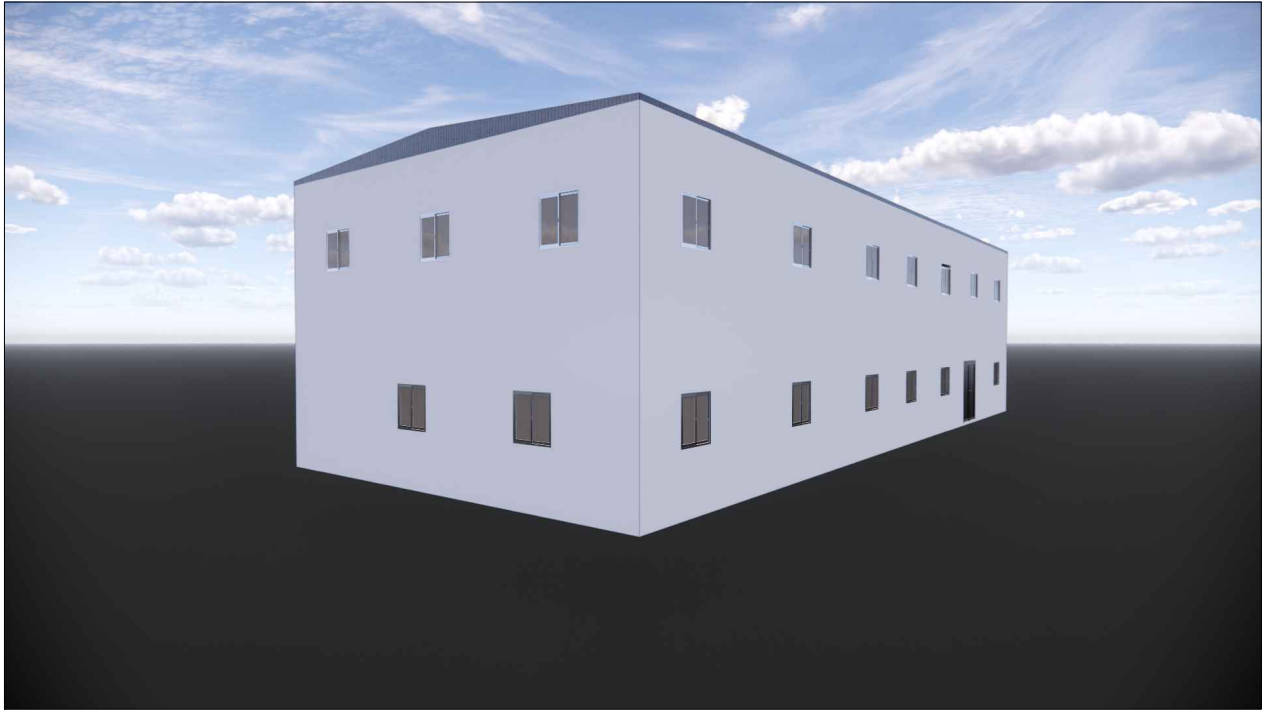

KEY PLAN:

NOTES:

- 1. ALL DIMENSIONS ARE IN MILLIMETERS UNLESS OTHERWISE SPECIFIES
- 2. DRAWINGS SHALL NOT BE SCALED. FOLLOW WRITTEN DIMENSIONS.
- 3. ALL DIMENSIONS TO BE VERIFIED ON SITE. ANY DISCREPANCIES SHOULD BE NOTIFIED TO THE ENGINEER.
- 4. READ THIS DRAWING IN CONJUNCTION WITH ALL CONSULTANTS AND SPECIALIST DRAWINGS, DETAILS, SCHEDULES AND SPECIFICATION
- 5. FOR RAMP DETAIL REFER TO P158.02-DL-PTS-SD-SAN-MI-9143.

03			
02			
01			
00	29-04-2025	FOR APPROVAL	HN
REV.	DATE:	DESCRIPTION	APPROVED BY:

CLIENT:

PROJECT/CONTRACT:

DRAWING TITLE:
G+1 SITE OFFICE CABIN

DRAWN BY:		CHECK BY:	
HASSAN NAWAZ			
SCALE:	DATE:	ACTUAL SIZE:	
1:40	29-04-2025	A3	
DRAWING NO. :			REV. : 00